



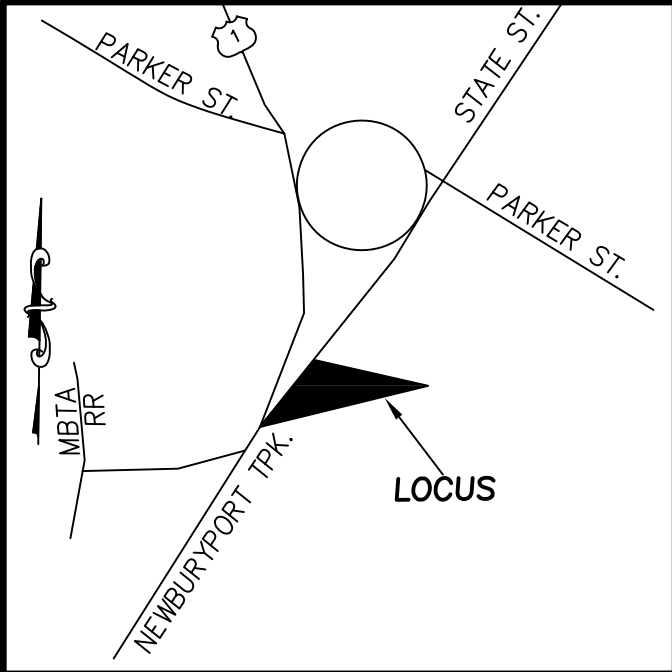

LOCUS MAP
N.T.S.

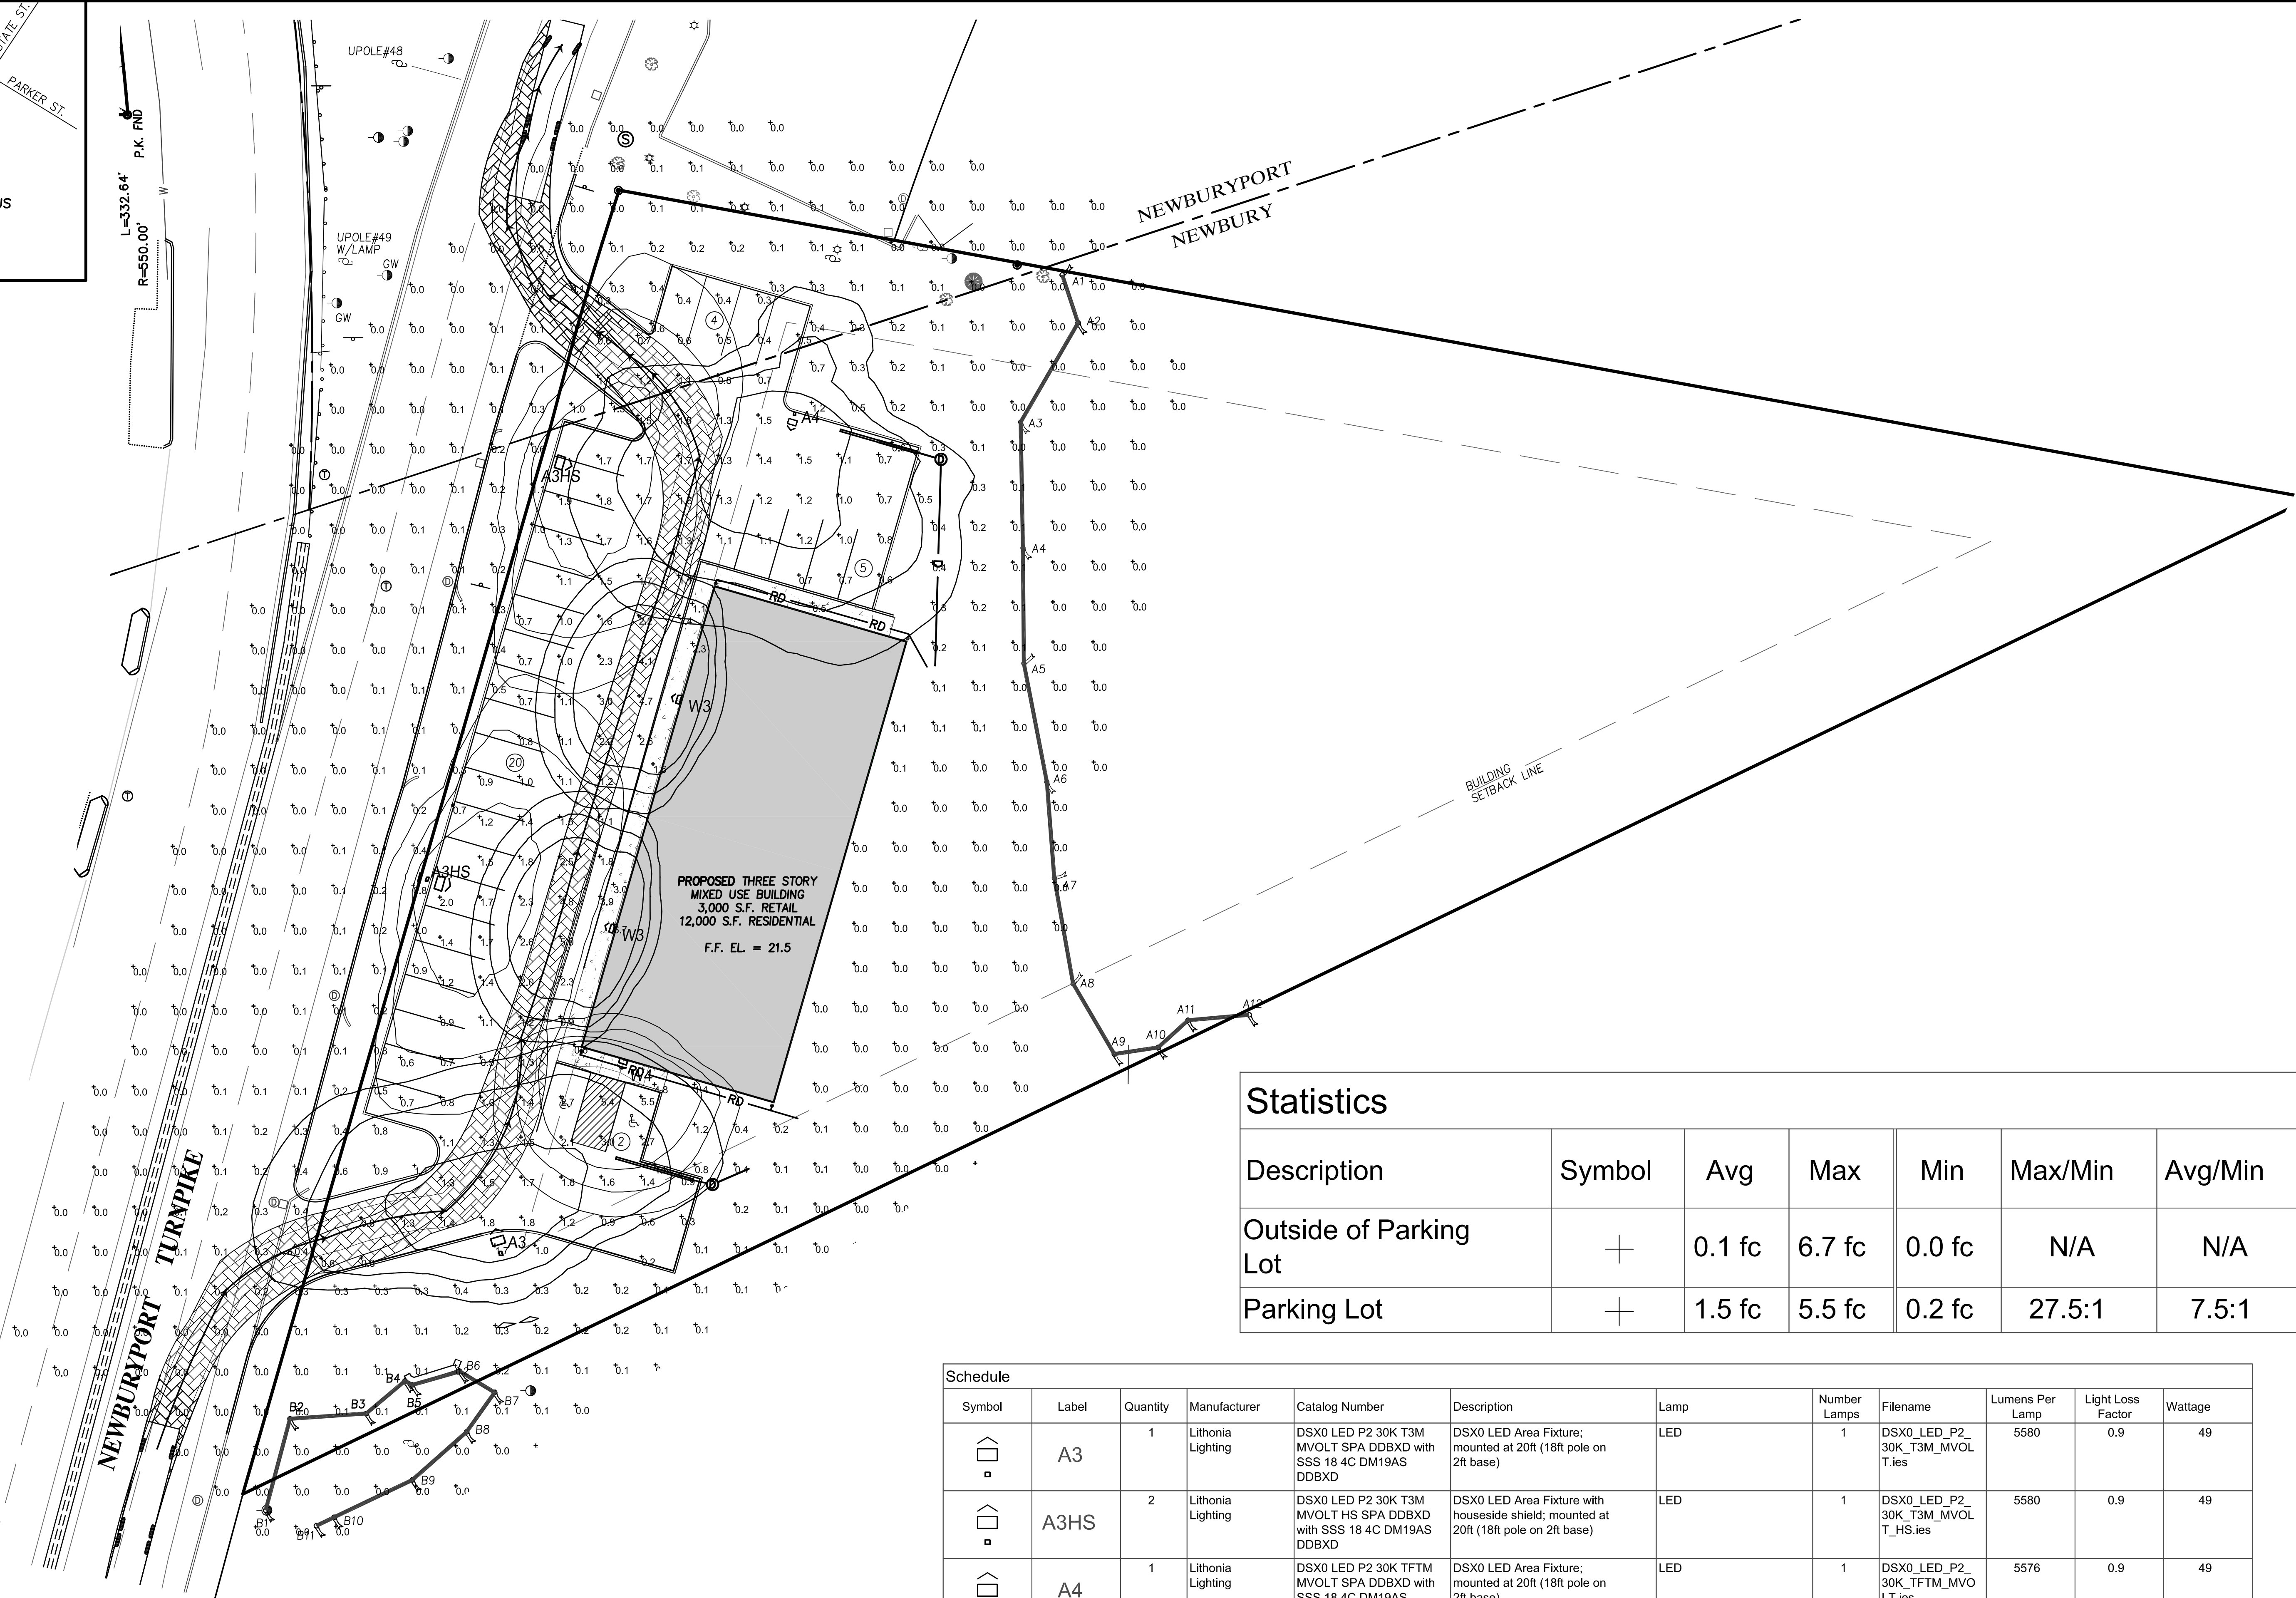

Statistics						
Description	Symbol	Avg	Max	Min	Max/Min	Avg/Min
Outside of Parking Lot	+	0.1 fc	6.7 fc	0.0 fc	N/A	N/A
Parking Lot	+	1.5 fc	5.5 fc	0.2 fc	27.5:1	7.5:1

Schedule											
Symbol	Label	Quantity	Manufacturer	Catalog Number	Description	Lamp	Number Lamps	Filename	Lumens Per Lamp	Light Loss Factor	Wattage
	A3	1	Lithonia Lighting	DSX0 LED P2 30K T3M MVOLT SPA DDBXD with SSS 18 4C DM19AS DDBXD	DSX0 LED Area Fixture; mounted at 20ft (18ft pole on 2ft base)	LED	1	DSX0_LED_P2_30K_T3M_MVOL T.ies	5580	0.9	49
	A3HS	2	Lithonia Lighting	DSX0 LED P2 30K T3M MVOLT HS SPA DDBXD with SSS 18 4C DM19AS DDBXD	DSX0 LED Area Fixture with houseside shield; mounted at 20ft (18ft pole on 2ft base)	LED	1	DSX0_LED_P2_30K_T3M_MVOL T_HS.ies	5580	0.9	49
	A4	1	Lithonia Lighting	DSX0 LED P2 30K TFTM MVOLT SPA DDBXD with SSS 18 4C DM19AS DDBXD	DSX0 LED Area Fixture; mounted at 20ft (18ft pole on 2ft base)	LED	1	DSX0_LED_P2_30K_TFTM_MVO LT.ies	5576	0.9	49
	W3	2	Lithonia Lighting	WDGE2 LED P4 30K 80CRI VW MVOLT DDBXD	WDGE2 LED Wall Pack; mounted at 16ft	LED	1	WDGE2_LED_P4_30K_80CRI_V W.ies	4096	0.9	34.96
	W4	1	Lithonia Lighting	WDGE2 LED P4 30K 80CRI VF MVOLT DDBXD	WDGE2 LED Wall Pack; mounted at 16ft	LED	1	WDGE2_LED_P4_30K_80CRI_VF .ies	4202	0.9	34.96

Site Lighting Layout
At
3 NEWBURYPORT TURNPIKE

Designer

Heidi G. Connors
Visible Light, Inc.
24 Stickney Terrace
Suite 6
Hampton, NH 03842

Date

5/7/21

Scale

1"=20'

Drawing No.

Summary